


REVISIONS:	
1	BIDDER'S RFI #1 1-19-18
2	BIDDER'S RFI #3 2-7-18


YONAH PRESERVE
 FOR THE
WHITE COUNTY BOARD OF COMMISSIONERS
 WHITE COUNTY, GEORGIA
COPYRIGHT © 2017 CARTER & SLOOPE, INC. ALL RIGHTS RESERVED.

Carter & Sloope
 CONSULTING ENGINEERS
MACON ♦ ATHENS ♦ CANTON ♦ MOULTRIE

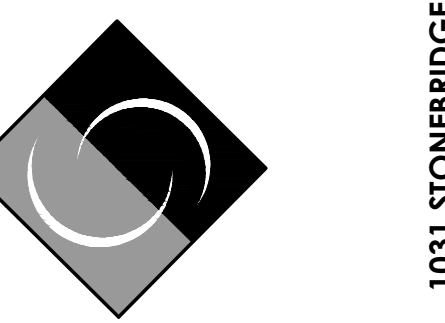


THIS LINE IS ONE INCH LONG WHEN DRAWING IS PLOTTED FULL SCALE	
DSGN: JHB	DRWN: JHB
DWG. NAME: W6299.008 MAIN	
PROJ. NO.: W6299.008	SHEET NO.: 7
DATE: DECEMBER 19 2017	OF 63 SHEETS

1031 STONEBRIDGE PARKWAY, WATKINSVILLE, GA 30677 • 706.769.4119 TEL. • 706.769.4546 FAX

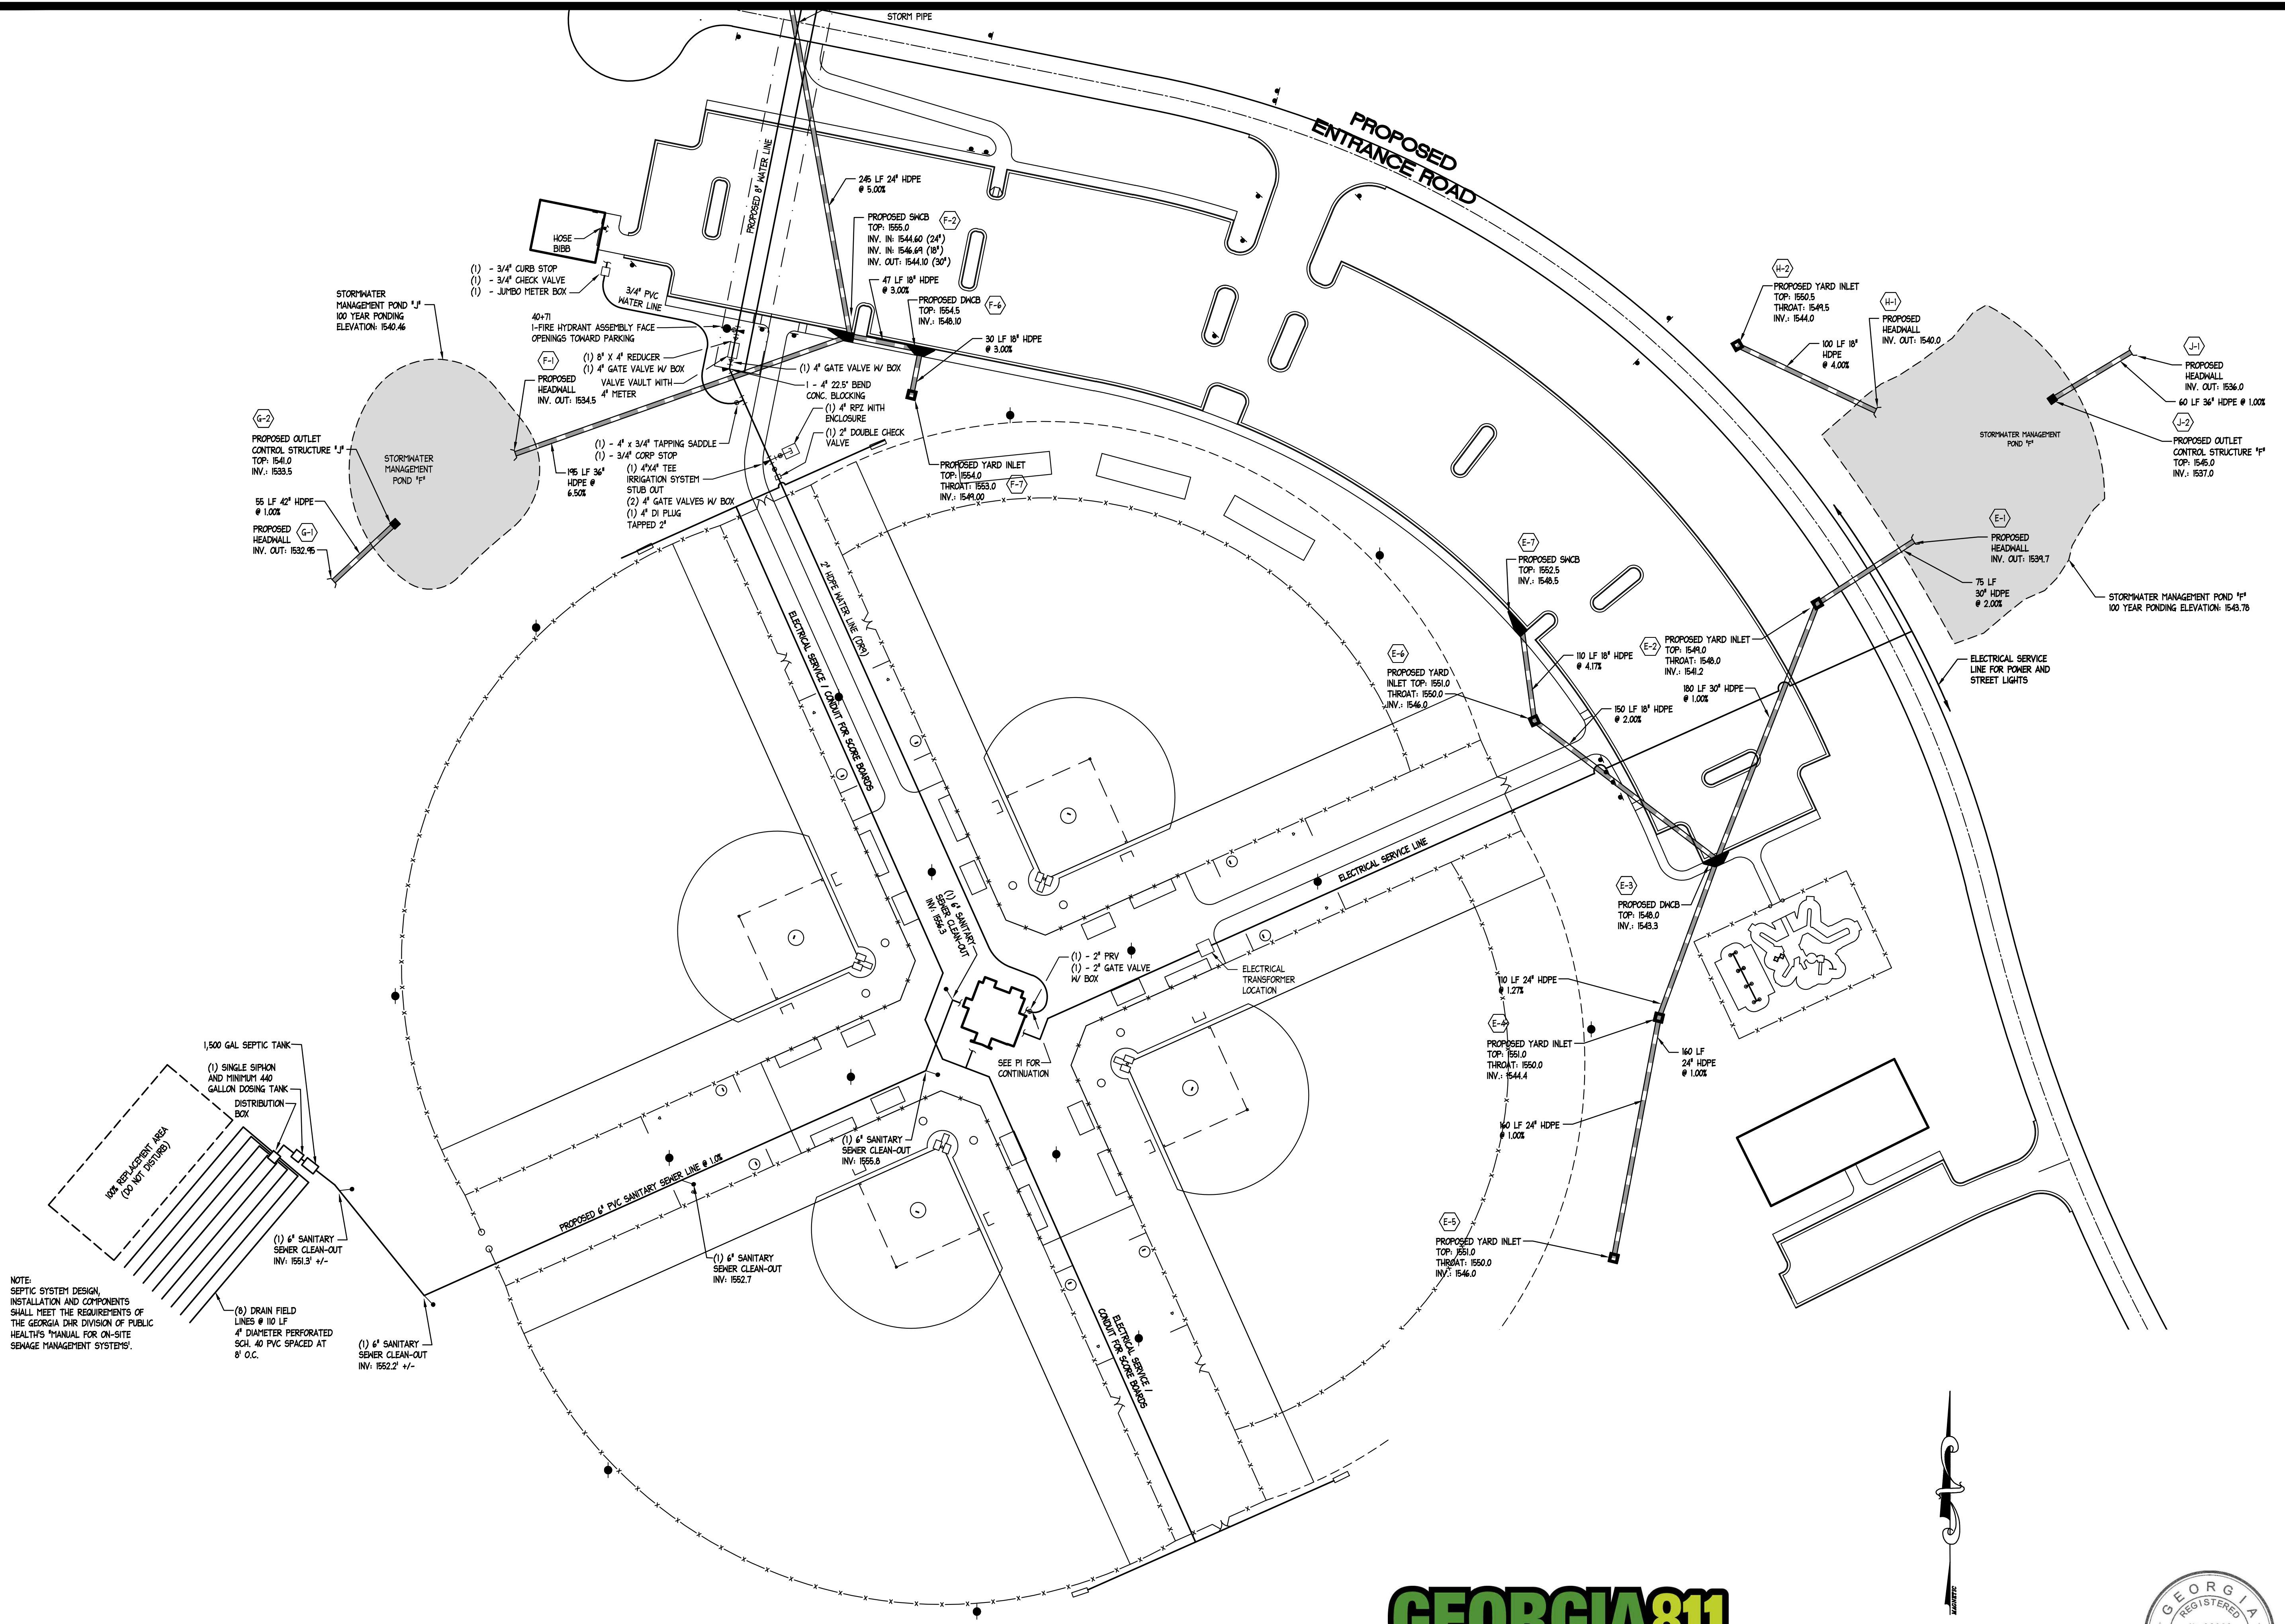

NOTE: SEPTIC SYSTEM DESIGN, INSTALLATION AND COMPONENTS SHALL MEET THE REQUIREMENTS OF THE GEORGIA DHR DIVISION OF PUBLIC HEALTH'S MANUAL FOR ON-SITE SEWAGE MANAGEMENT SYSTEMS.

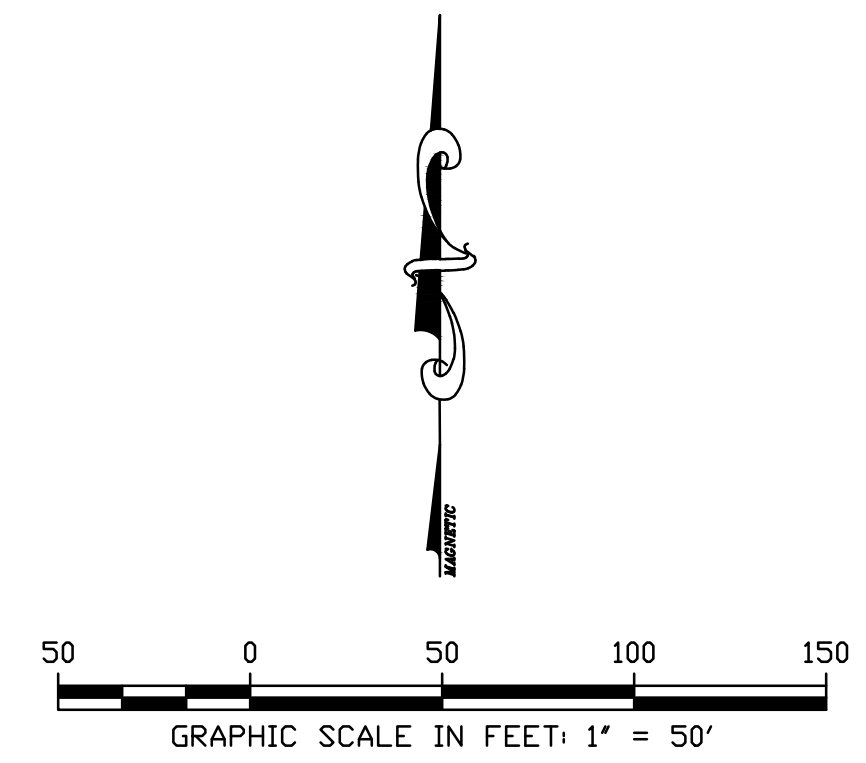

GSWCC Certification #: 0000046529
Expires: 10-28-2019

UTILITY PLAN